


GENERAL ARRANGEMENT  
PROFILE VIEW

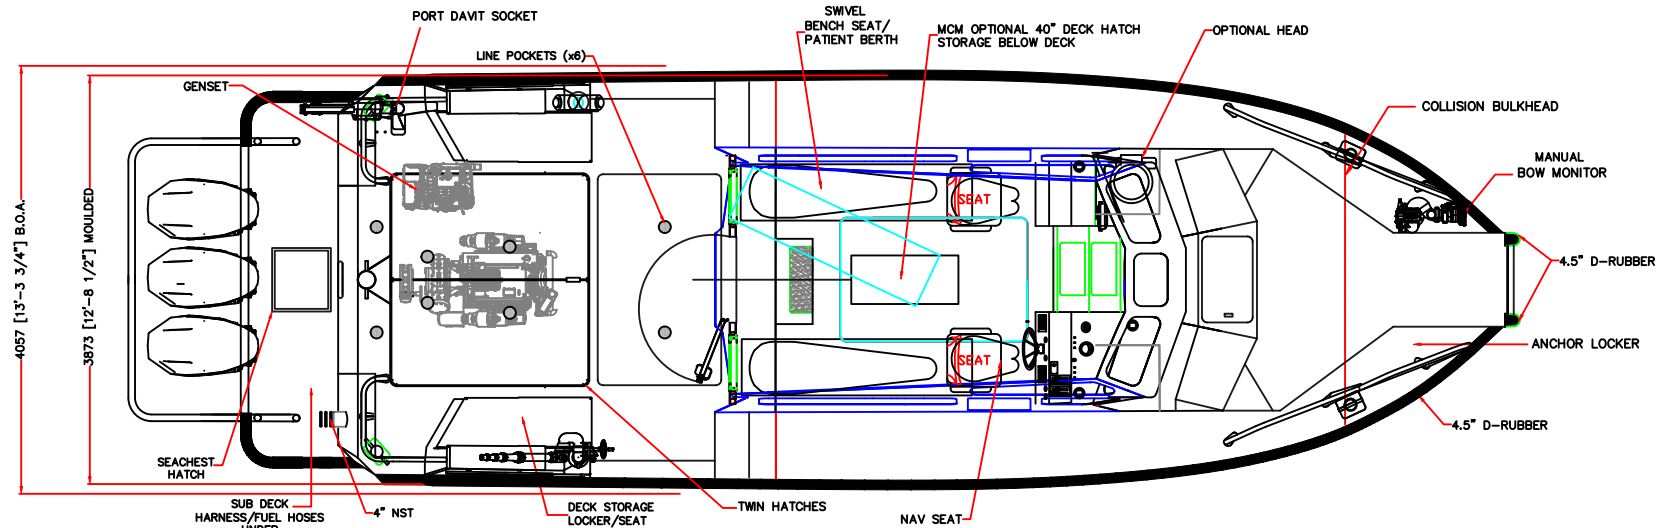

GENERAL ARRANGEMENT  
PLAN VIEW

**VESSEL PARTICULARS:**

LOA:	13.189M (43'-3")
BEAM MAXIMUM	4.057M (13'-4")
LENGTH MOULDED	11.9M (39'-4")
BEAM MOULDED	3.873M (12'-8 1/2")
DEADRISE:	22°
PROPULSION	
MAIN ENGINES:	(3 OUTBOARDS) 1200HP
<b>FIRE SYSTEM</b>	
PUMP:	(1) DARLEY 1500
PIPING:	VARIOUS Ø ALUMINIUM

NOTE: SOME OPTIONS MAY BE SHOWN

**METALCRAFT MARINE  
INCORPORATED**

SOLOMONS  
VOLUNTEER RESCUE SQUAD  
AND FIRE DEPARTMENT

36FT FIRESTORM  
ENGINEERING AND INTEGRATION  
SHIPBUILDER DRAWINGS  
GENERAL ARRANGEMENT  
OB PLAN AND PROFILE

SIZE	FSCM CAGE NO.	DRAWING NO.	REV
B	1T8W7	FS36-81400-801-001	BO
SCALE	1:50	STATUS: PRELIMINARY	SHEET 1 OF 1

© METALCRAFT MARINE INC. 2024